

Address	Additional Refrigerant
051	12.00 kg


  

Symbol	Definition
#1	Standard
#2	Usable (Unit performance will be affected)
#3	Usable (Refrigerant charge will be limited)
#4	Usable (Piping length will be limited)
#5	Piping length and vertical separation will be limited




  

PIPING LIST				
SYMBOL	BRANCH	PIPE	MODEL	NAME
J1	CMY	Y100VBK3		
J2	CMY	Y202S-G2		
J3	CMY	Y102SS-G2		
J4	CMY	Y102LS-G2		
SYMBOL	LIQUID	PIPE/GAS	PIPE	SIZE
P1	12.7			
P2	9.52			
P3		22.2		
P4	15.88		28.58	
P5	6.35	12.7		
P6	9.52		19.05	
P7	12.7		28.58	
P8	9.52		15.88	

## PIANO SEMINTERRATO

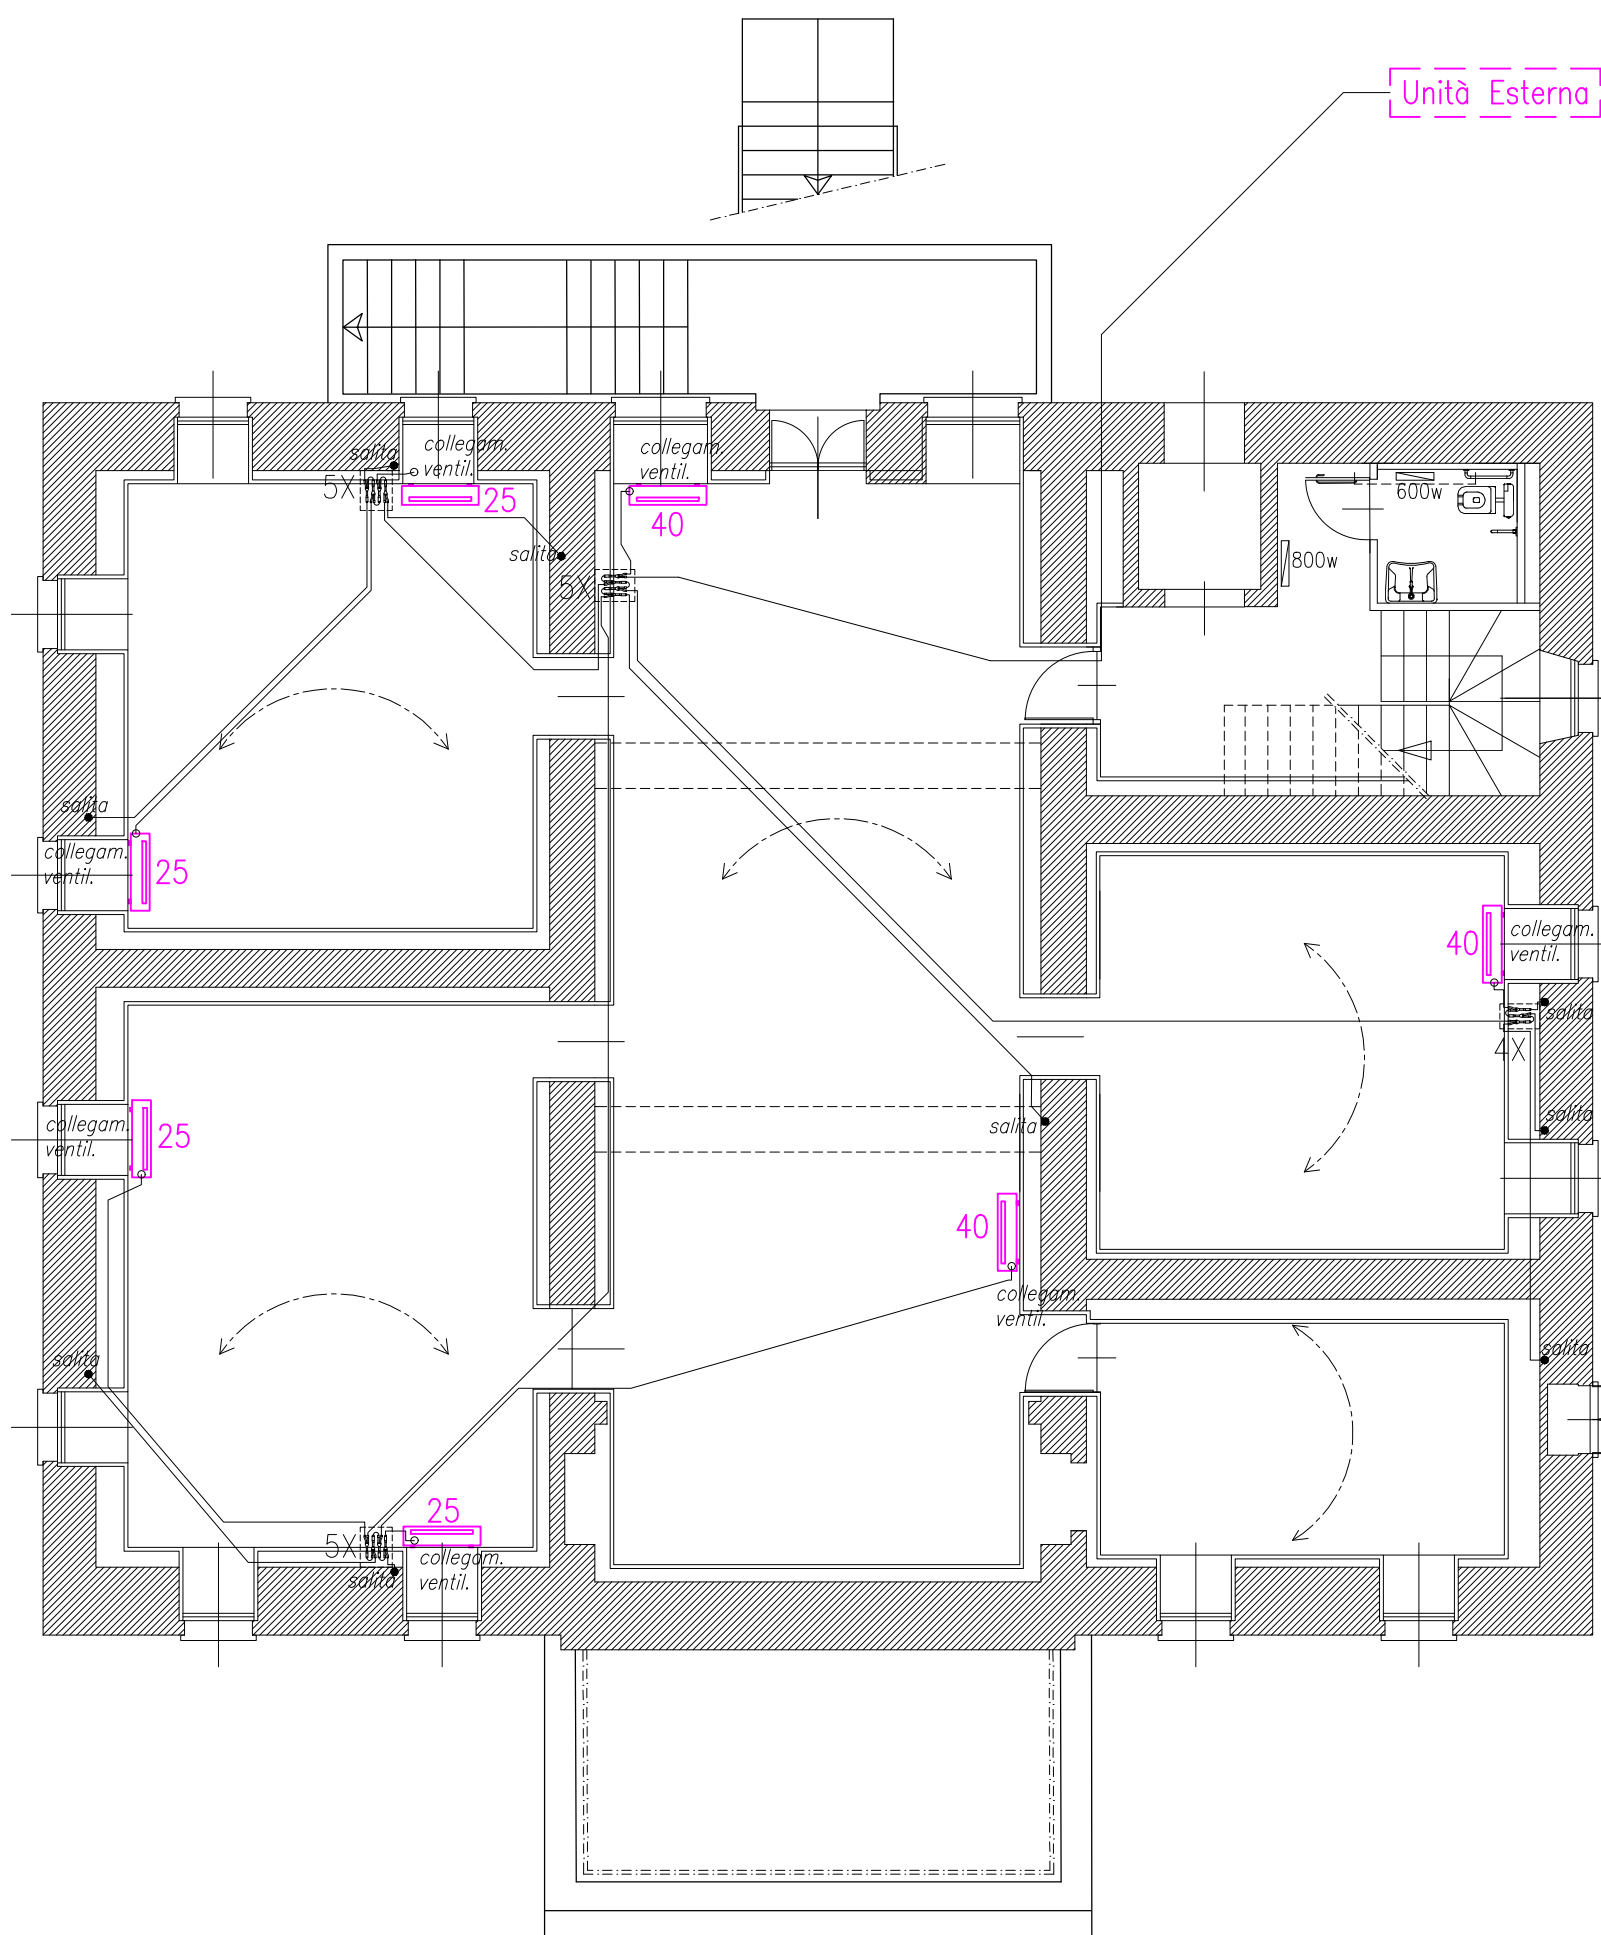

## PIANO RIALZATO

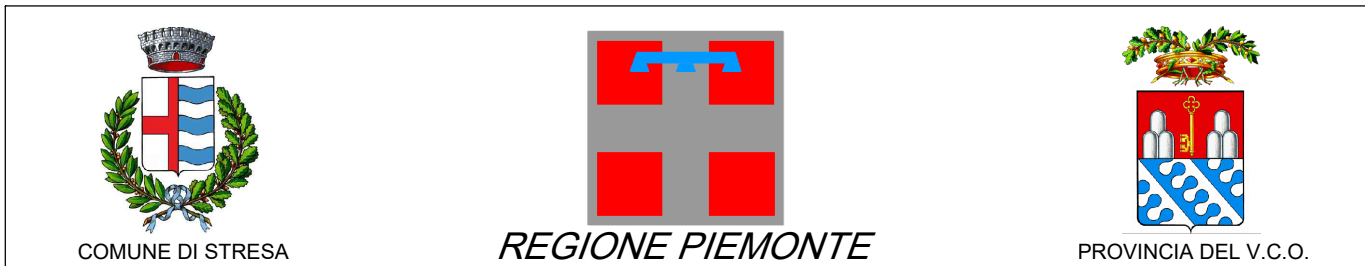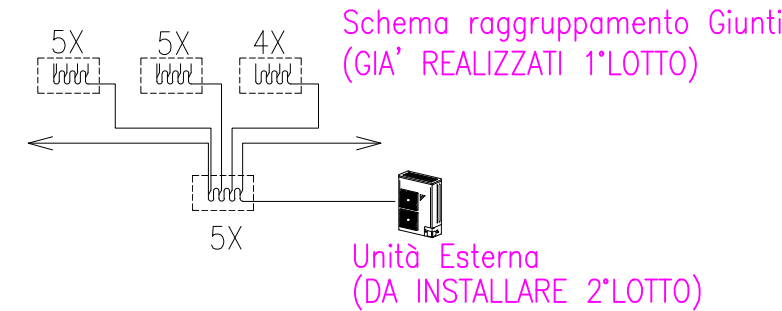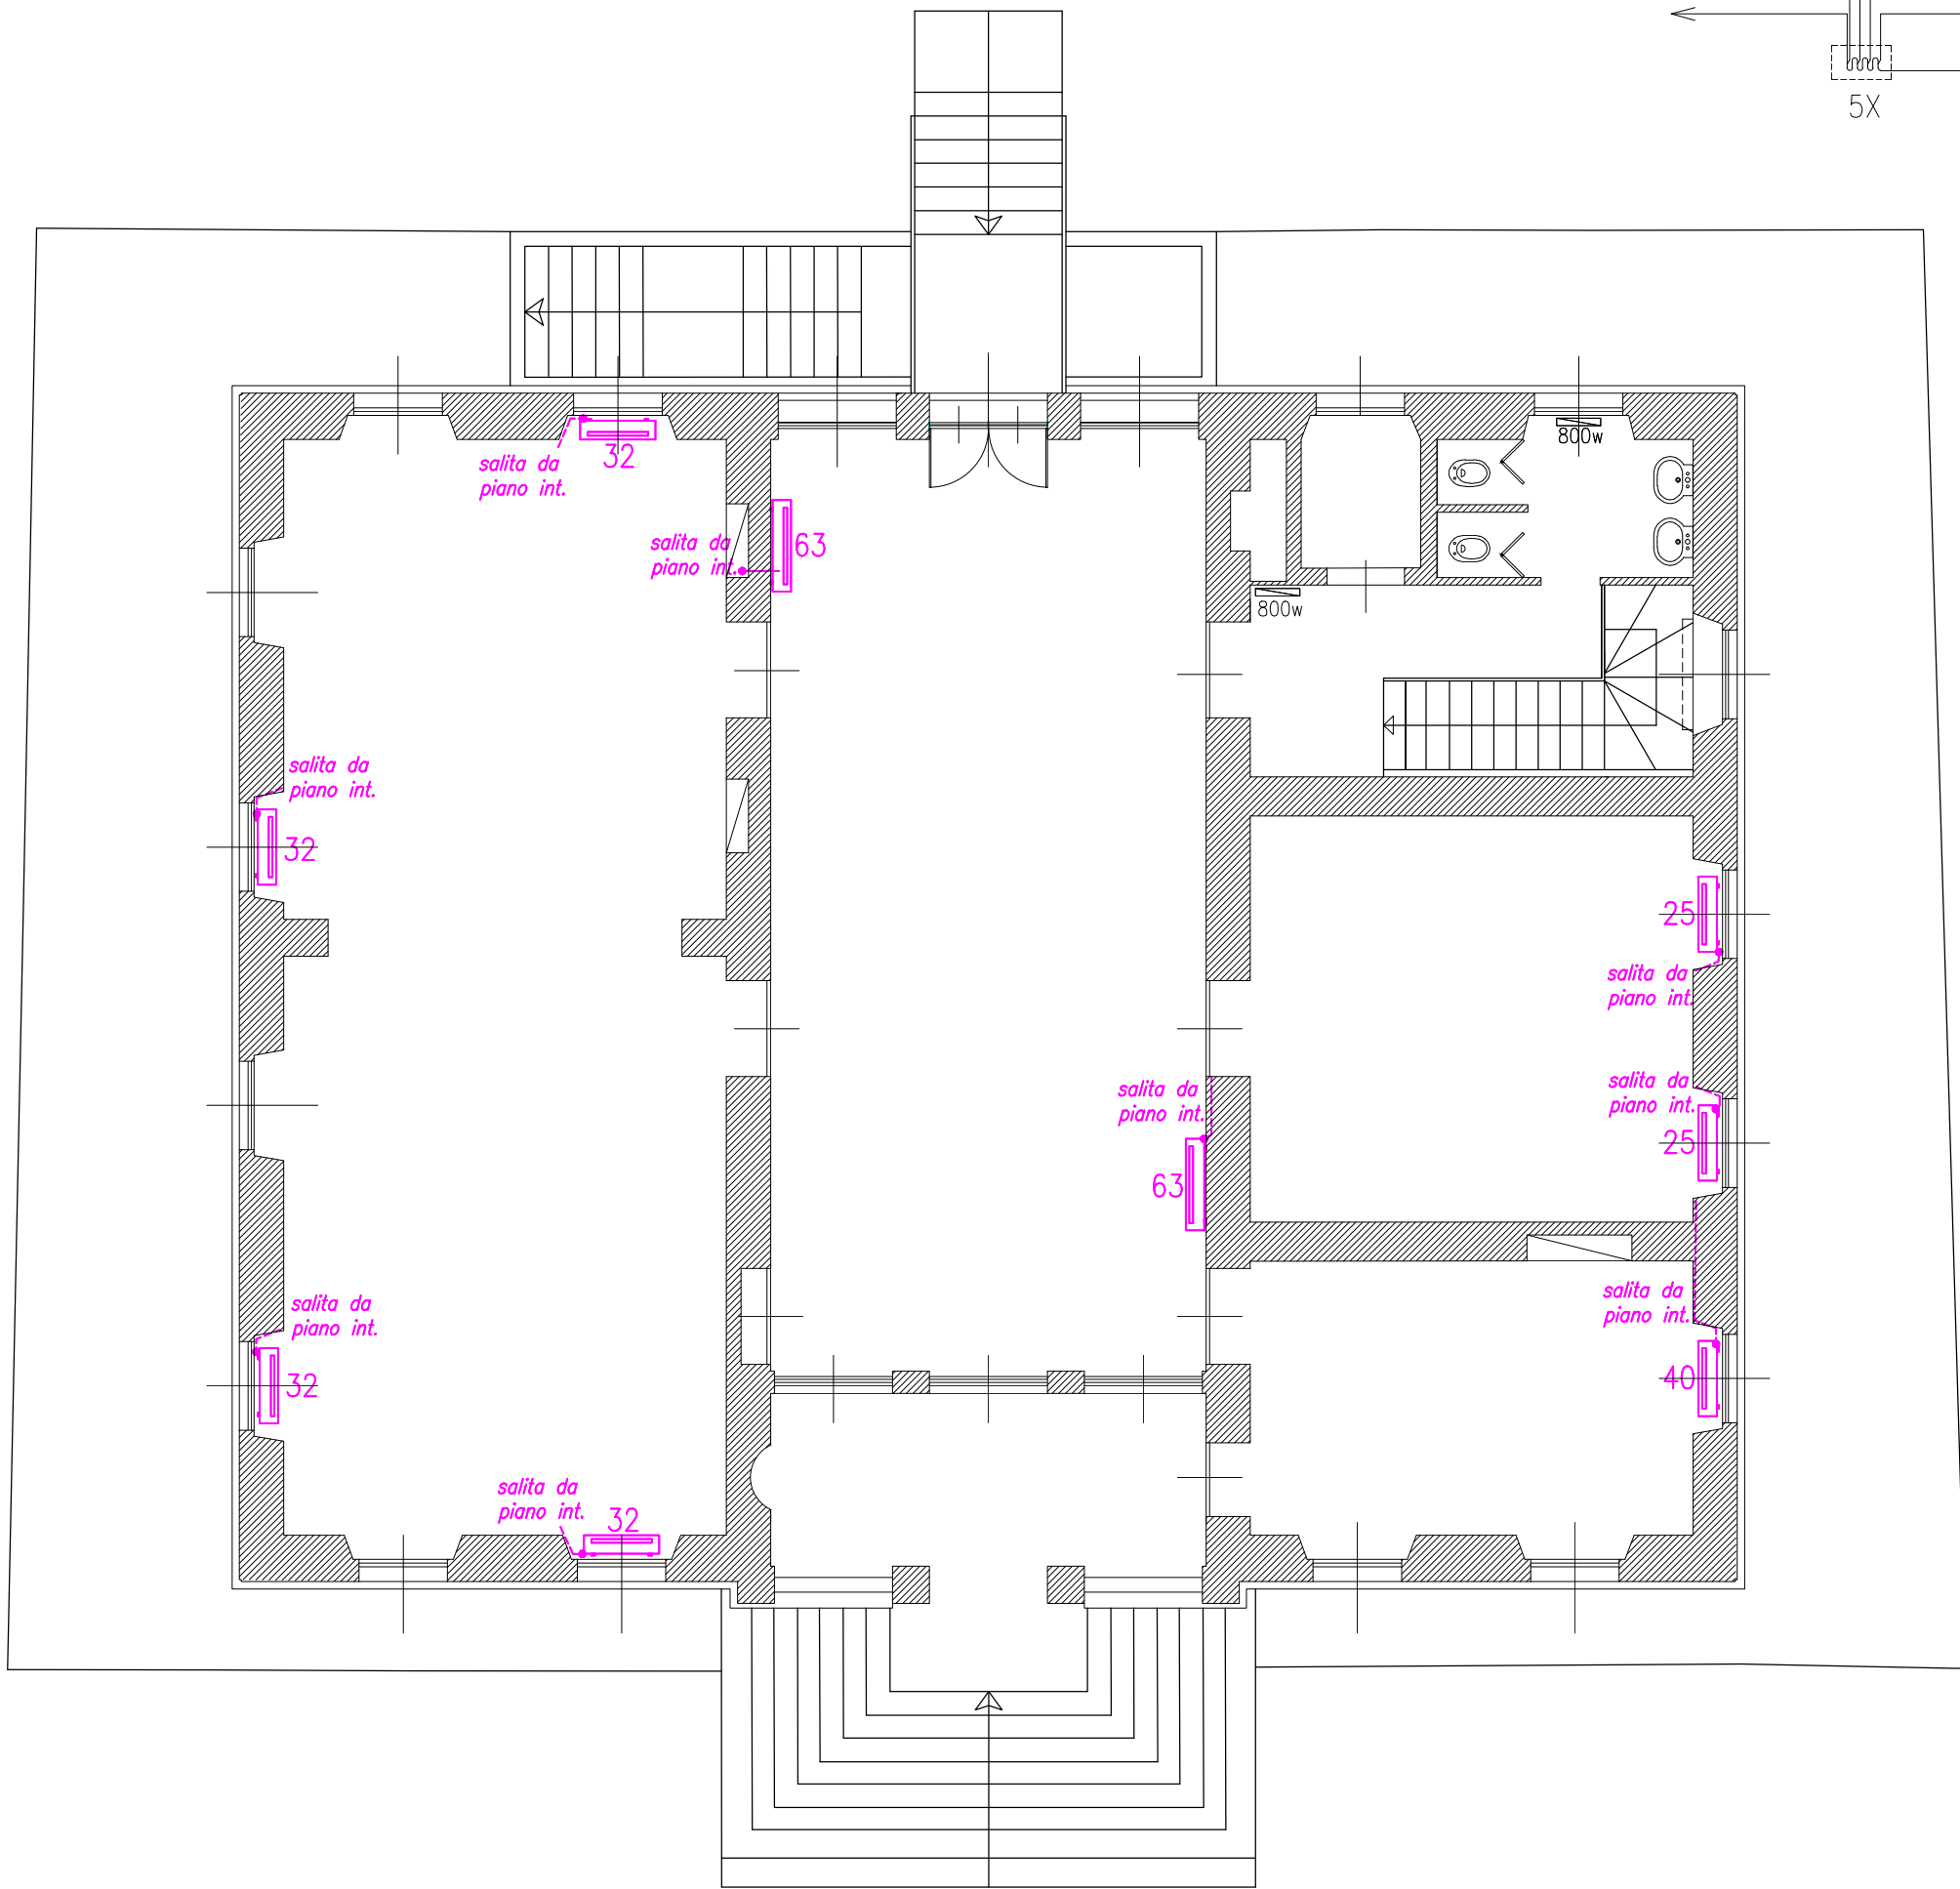

### COMUNE DI STRESA

LAVORI DI RESTAURO PALAZZINA LIBERTY - LOTTO N°2  
DI COMPLETAMENTO ED OPERE DI SISTEMAZIONE  
RECINZIONE ED AREE ESTERNE - CUP G69122001460004

Committenza:

**Comune di STRESA**

Progetto:

**PROGETTO ESECUTIVO 2° LOTTO**

Elaborato:

**IMPIANTO CLIMATIZZAZIONE**

File name: meccanici.dwg

Scala 1:100

Progettazione:

FALCIOLA ING. FRANCO  
n.123 Ordine Ingegneri VCO  
FALCIOLA ARCH. GIOVANNA  
n.250 Ordine Architetti Pianificatori,  
Paesaggisti e Conservatori Novara e VCO  
Via Bonomelli n°16  
28845 DOMODOSSOLA (VB)  
tel/fax 0324 249322  
email: studiotecnico@falconi@gmail.com

Visti:

Tavola n°:

**02MEC**

Data: OTTOBRE 2023  
Agg:

Committenza:

Progettazione impianti:

TORI PER. IND. MAURIZIO  
n.59 Albo Periti Industriali VCO  
Via Turati n°7  
28845 DOMODOSSOLA (VB)  
tel/fax 0324 240913  
email: mautori@tin.it